



CHABOT-LAS POSITAS COMMUNITY COLLEGE DISTRICT PURCHASING DEPARTMENT

August 12, 2026

Addendum No. 01 **INVITATION TO BID.: B26-27-02** **Soccer Scoreboard Project at Las Positas College**

To: All Prospective Bidders

This Addendum One (01) is issued to incorporate the following changes, additions or deletions to the Invitation to Bid.: B26-27-02 Soccer Scoreboard Project at Las Positas College. Any modifications/changes made by this addendum affect only the portions or paragraphs specifically identified herein; all remaining portions of the IFB B26-27-02 to remain in force. It is the responsibility of all responders to conform to this addendum.

A. ADDITIONS, CHANGES AND/OR CLARIFICATIONS:

Change to General Conditions Articles 8.3.7.2 and 8.3.7.3 ...to a policy "obtained by the District" are hereby corrected by this Addendum to read, "Obtained by the Contractor. Builder's Risk insurance is to be obtained by the Contractor. See General Conditions Articles 6.3, 6.4.2 and 6.7, and Special Conditions Article 2.1, "Insurance Requirements for Contractor," which sets the Builder's Risk coverage amount at the full value of the Work. The references in General Conditions Articles 8.3.7.2 and 8.3.7.3 to a policy "obtained by the District" are hereby corrected by this Addendum to read "obtained by the Contractor." Please also refer to Special Conditions Article 2.1, "Insurance Requirements **for Contractor**," which sets the Builder's Risk coverage amount at the full value of the Work.

Specification Revisions:

Specification Section 01 11 00, Article 1.08.a is revised to read: "No work, delivery of equipment or materials shall take place outside the permitted work hours stated in Addendum No. 1 without written authorization by the Owner's Representative."



CHABOT-LAS POSITAS COMMUNITY COLLEGE DISTRICT PURCHASING DEPARTMENT

Drawing Revisions:

Sheet S1.1 – Scoreboard Schematic Elevation, dated 08/10/2026, Revision 1 (Addendum #1 – Model # & Weights), is issued with and attached to this Addendum and replaces Sheet S1.1 dated 05/05/2026 in its entirety.

Sheets E0.2 – Details and E1.0 – Electrical Plan, dated 08/10/2026, Revision 1, are issued with and attached to this Addendum and replace the previously issued sheets in their entirety.

B. RFI QUESTIONS AND RESPONSES:

QUESTION 1: Could you please provide the engineer's estimate for the "Soccer Scoreboard Project - Las Positas College?"

RESPONSE 1: \$240,000.00

QUESTION 2: Good afternoon, we are interested in bidding as a general on this job. The bid is requiring a B license, which is for building construction. Would an A license with a C-10 electrical subcontractor be acceptable?

RESPONSE 2: Class B – General Building Contractor license is required for this project. An A license with a C-10 electrical subcontractor is not acceptable.

QUESTION 3: We are interested in bidding on the Soccer Scoreboard Project at Las Positas College and would like to kindly request the Engineer's Estimated Project Cost for our reference

RESPONSE 3: \$240,000.00

QUESTION 4: Is the soccer scoreboard to be furnished by the General Contractor or by the District?

RESPONSE 4: The scoreboard is to be furnished and installed by the General Contractor. Refer to Specification Section 32 33 00 – Site Furnishings, Article 2.02. No portion of the scoreboard assembly is Owner-furnished.



CHABOT-LAS POSITAS COMMUNITY COLLEGE DISTRICT PURCHASING DEPARTMENT

QUESTION 5: If the General Contractor is to furnish the scoreboard, is the support structure (including columns, mounting hardware, anchor hardware, and other related accessories) included as part of the scoreboard manufacturer's package, or is it to be furnished separately by the General Contractor?

RESPONSE 5: I-Beam Mounting Hardware for two (2) I-Beams is included in the manufacturer's package per Specification Section 32 33 00, Article 2.02.C.9. The structural steel W-columns, pier foundations, reinforcing, and concrete collars are the Contractor's scope and are not part of the manufacturer's package. Refer to Structural Drawing S1.1 and DSA Pre-Checked Structural Document Sheets SB1–SB9 (P.C. 04-122194).

QUESTION 6: If the General Contractor is to furnish the scoreboard, could you please provide the specified manufacturer and model number? If approved equal products are permitted, could you also provide the list of acceptable manufacturers?

RESPONSE 6: The specified scoreboard is Daktronics model SO-2019-W-PV-F PanaView Soccer Scoreboard per Specification Section 32 33 00, Article 2.02. There is no pre-approved list of alternate manufacturers. Requests for Substitution shall be submitted in accordance with Specification Section 01 25 00 – Substitution Procedures. Per Specification Section 01 25 00, Article 1.04.C, all costs associated with a Substitution request, including any DSA review and approval required as a result of the substitution, shall be borne by the Contractor.

QUESTION 7: Kindly provide the estimated project cost.

RESPONSE 7: The Engineer's Estimate is \$240,000.00. See responses to Questions 1 & 3.

QUESTION 8: Please confirm retention will be withheld at 5%.

RESPONSE 8: Confirmed. Retention will be withheld at five percent (5%). Refer to the General Conditions, which provide for payment of ninety-five percent (95%) of the value of Work in each Application for Progress Payment in accordance with Public Contract Code §20104.50.

QUESTION 9: Please confirm there are no SBE/DBE/DVBE participation goals or good-faith-effort documentation requirements for this bid.

RESPONSE 9: There are no SBE/DBE/DVBE participation goals or good-faith-effort documentation requirements for this bid.



CHABOT-LAS POSITAS COMMUNITY COLLEGE DISTRICT PURCHASING DEPARTMENT

QUESTION 10: Please confirm permitted working hours, any quiet-hour or instruction-period noise restrictions, and whether night/weekend work is required or permitted for disruptive activities (demolition, coring, fire alarm testing).

RESPONSE 10: Noise control is always favorable. The City of Livermore work hours are limited to: 7am to 7pm Monday – Friday, Saturday work 9am – 5pm and No Sunday work. Work on campus must fall within the city limitations and must also adhere to the scheduling provisions set forth in the contract documents, including but not limited to General Conditions Article 4.20 which limits construction activities to the District's hours and days set forth in the Special Conditions, except in an emergency. This window identifies the outer limit of allowable working hours - it is not a directive or permission to perform Work throughout the full window, and any Work outside normal business hours remains subject to District authorization per GC 4.20 and GC 4.18.5.3.

QUESTION 11: Is the Daktronics scoreboard OFCI?

RESPONSE 11: No. The Daktronics scoreboard is Contractor-furnished and Contractor-installed. Refer to Response 4.

QUESTION 12: Is the radio control system OFCI?

RESPONSE 12: No. The Outdoor Scoreboard Radio Communications Transmitter, Radio Receiver, and All Sport Radio Antenna Extension Kit are included in the Contractor-furnished scoreboard package per Specification Section 32 33 00, Article 2.02.C.6, C.7, and C.8.

QUESTION 13: Is the 12VDC trumpet horn with power supply for outdoor scoreboard OFCI?

RESPONSE 13: No. The 12VDC Trumpet Horn with Power Supply is included in the Contractor-furnished scoreboard package per Specification Section 32 33 00, Article 2.02.C.4.

QUESTION 14: Please advise if SWPPP is required.

RESPONSE 14: No SWPPP is required. BMPs still required per the General Notes.



CHABOT-LAS POSITAS COMMUNITY COLLEGE DISTRICT PURCHASING DEPARTMENT

QUESTION 15: Please confirm 60% of work is performed during off-hours. What specific time blocks qualify as "off-hours" for the 60% requirement?

RESPONSE 15: The 60% off-hours provision does not apply to this Project. Specification Section 01 11 00, Articles 1.01.D and 1.01.E are revised by this Addendum to delete the off-hours requirement. Permitted work hours are as stated in Response 10 above. See Specification Revisions below.

QUESTION 16: Can the District confirm that Panel B at the parking lot lighting pedestal has a spare 20A/1P circuit breaker available for this connection? If a spare breaker does not exist, what work is within GC scope to accommodate the new circuit — breaker replacement, panel expansion, or a new sub-panel?

RESPONSE 16: The parking lot lighting control pedestal has two (2) spare 30A/1P circuit breakers on the upper row. Sheet E1.0 has been revised by this Addendum. Per revised Keynote 5, the Contractor shall replace one (1) existing spare 30A/1P circuit breaker with a new 15A/1P circuit breaker of the same type and interrupting rating and connect to the new step-down transformer. Refer to revised Sheet E1.0 issued with this Addendum. See photo attached on last page.

QUESTION 17: What items, if any, are designated as DSA Deferred Approval items for this project? Is the structural steel connection design a deferred approval item? Are any electrical items (panel connections, disconnect switch mounting on scoreboard post) deferred approvals?

RESPONSE 17: There are no deferred submittals.

All other terms and conditions remain unchanged.


Michael McClung - Buyer, Purchasing and Warehouse Services
Chabot-Las Positas Community College District



CHABOT-LAS POSITAS COMMUNITY COLLEGE DISTRICT PURCHASING DEPARTMENT

[illegible]

ALL IDEAS, DESIGNS, ARRANGEMENTS, AND PLANS INDICATED OR REPRESENTED BY THIS DRAWING ARE OWNED BY AND THE PROPERTY OF VERDE DESIGN, INC. AND WERE CREATED, EVOLVED, AND DEVELOPED FOR USE ON AND IN CONNECTION WITH THE SPECIFIED PROJECT. NONE OF SUCH IDEAS, DESIGNS, ARRANGEMENTS OR PLANS SHALL BE USED, REPRODUCED, OR PUBLISHED BY ANY METHOD, IN WHOLE OR IN PART, OR DISCLOSED TO ANY PERSON, FIRM, OR CORPORATION FOR ANY PURPOSE WHATSOEVER WITHOUT WRITTEN PERMISSION OF VERDE DESIGN, INC.

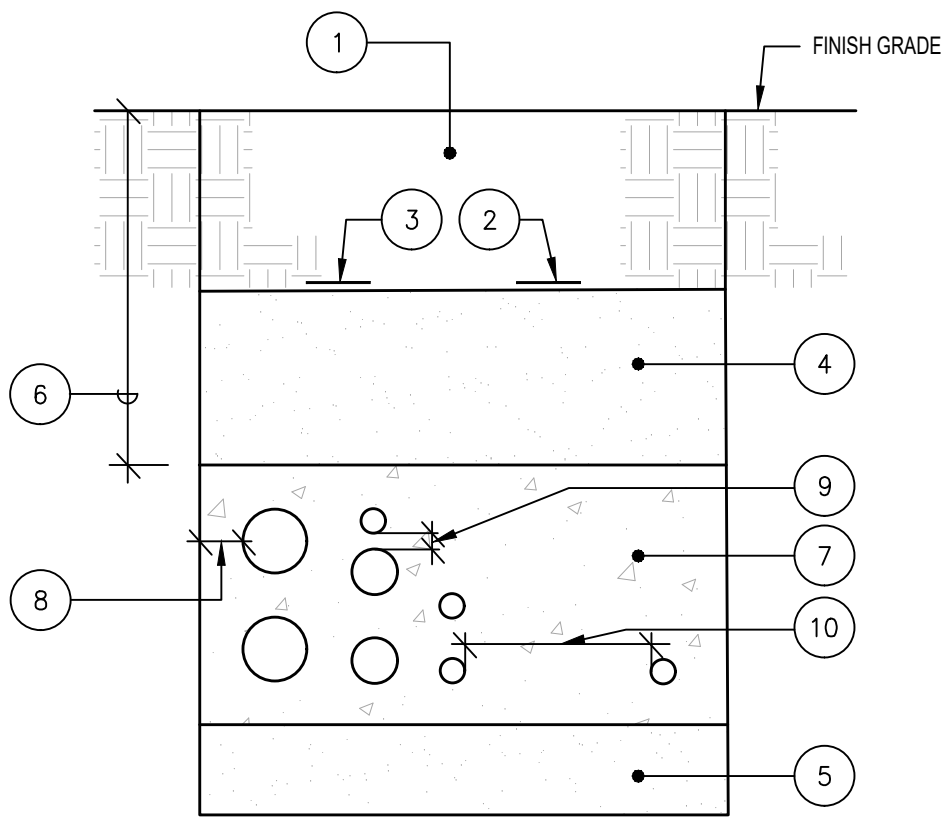


- DUCT BANK NOTES
- 1 NATIVE SOIL BACKFILL.
 - 2 3" WIDE WARNING TAPE LOCATED 12" BELOW GRADE. TAPE SHALL INDICATE: "CAUTION BURIED ELECTRICAL CONDUIT".
 - 3 3" WIDE WARNING TAPE LOCATED 12" BELOW GRADE. TAPE SHALL INDICATE: "CAUTION BURIED COMMUNICATIONS CONDUIT".
 - 4 DAMP SAND BACKFILL TO WITHIN 12" OF FINISH GRADE.
 - 5 6" BED OF DAMP SAND.
 - 6 36" IN TRAFFIC AREAS, 24" (FOR ELECTRICAL) 30" (FOR TELECOM) IN NON-TRAFFIC AREAS.
 - 7 CONCRETE ENCASEMENT, WHERE REQUIRED BY SPECIFICATION.
 - 8 3" MINIMUM COVERAGE.
 - 9 3" BETWEEN IDENTICAL SYSTEM CONDUITS.
 - 10 12" BETWEEN DIFFERENCE SYSTEM CONDUITS.

DUCT BANK

SCALE:
NTS


3

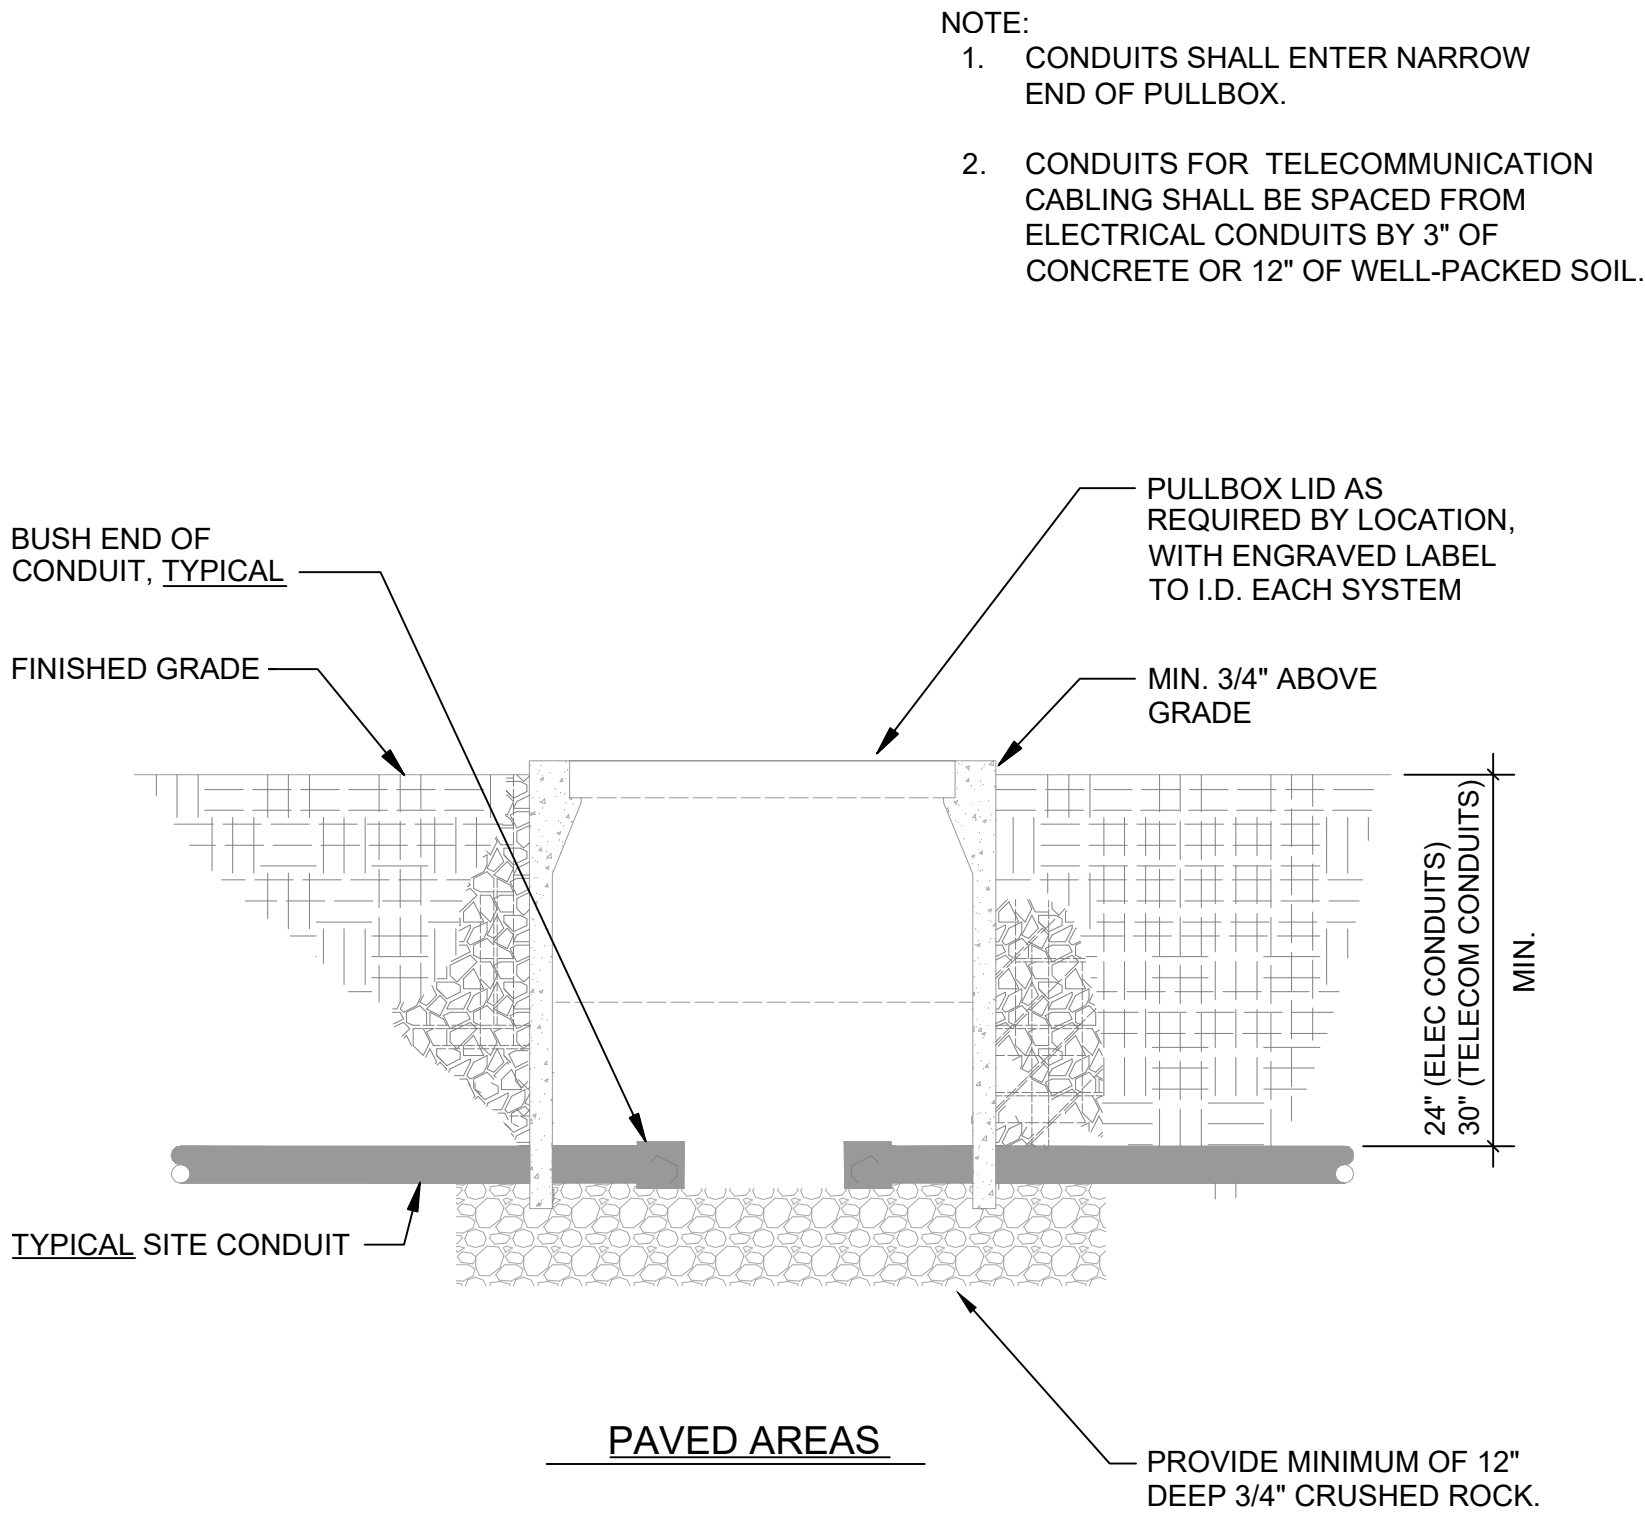

TYPICAL PULLBOX DETAIL

SCALE:
NTS


2

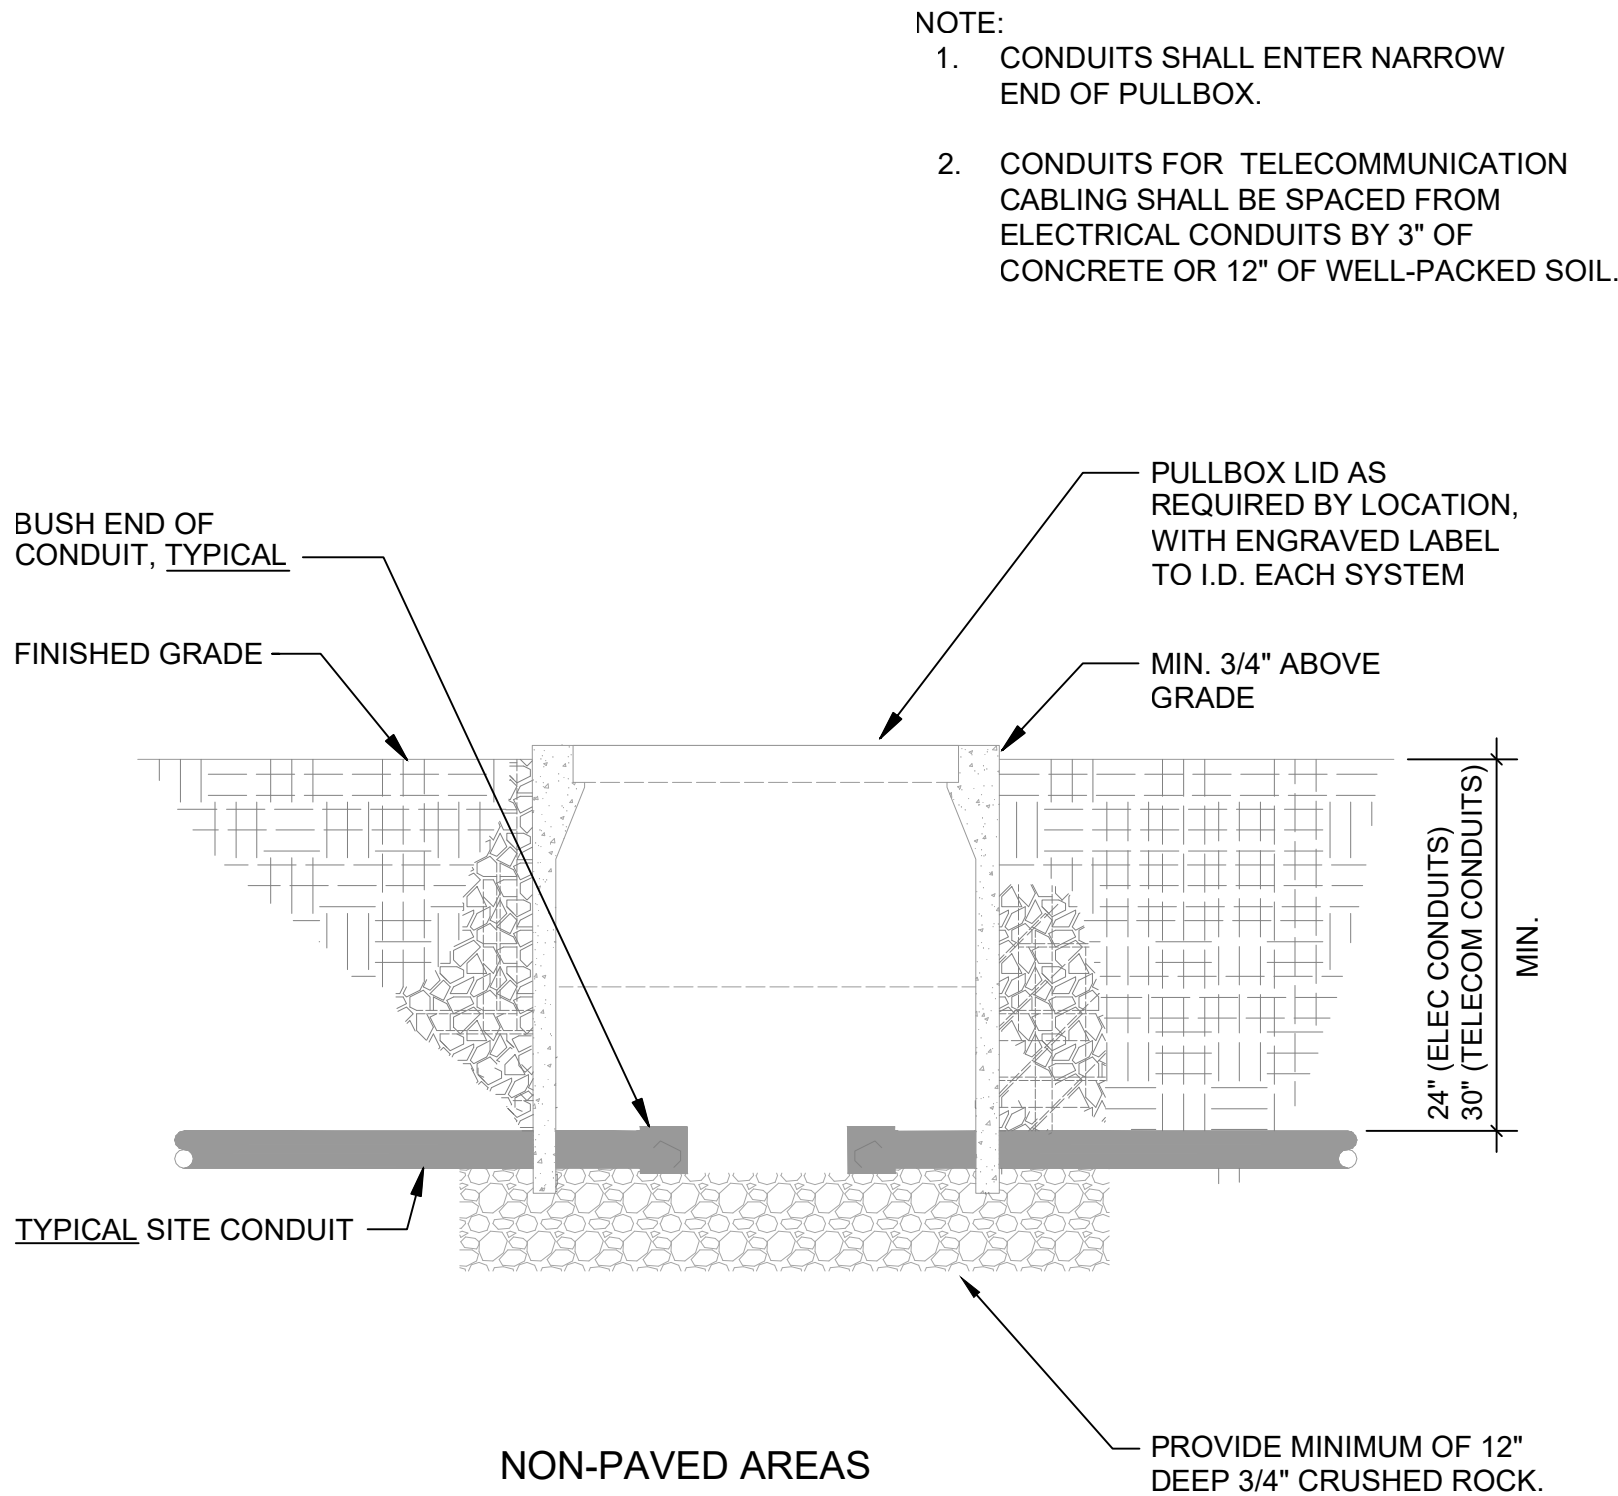

TYPICAL PULLBOX DETAIL

SCALE:
NTS

1

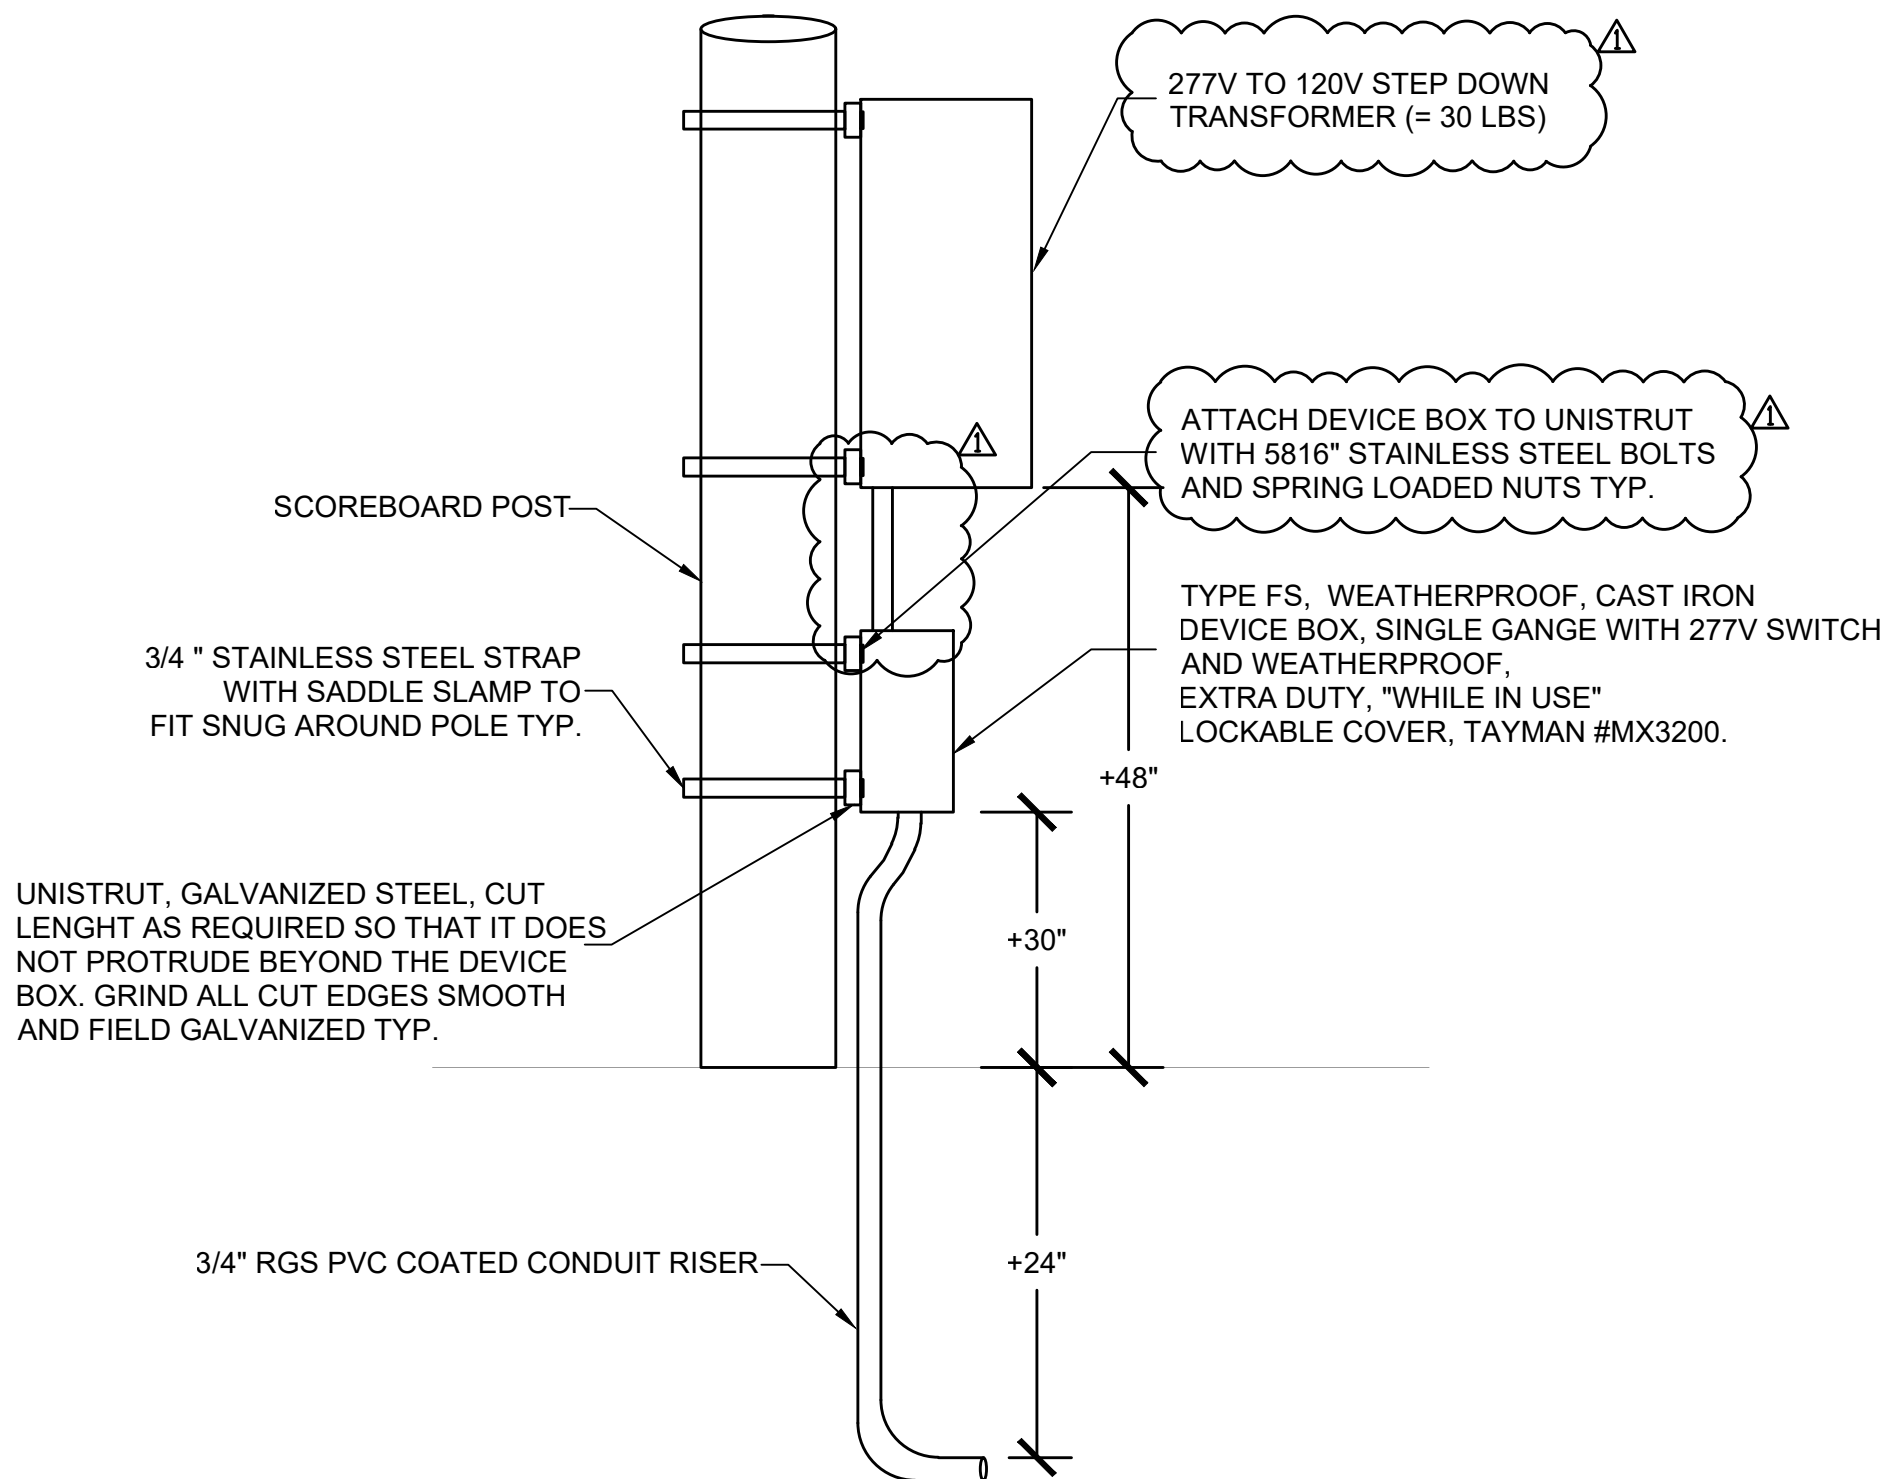

SCOREBOARD POST MOUNTED SWITCH AND TRANSFORMER DETAIL

SCALE:
NTS

4

NOT USED

SCALE:
NTS

6

NOT USED

SCALE:
NTS

5



CONSULTANT

DETAILS

ATHLETIC OUTDOOR
COURTS - SOCCER
SCOREBOARD PROJECT

3000 CAMPUS HILL DRIVE
LIVERMORE, CA 94551

SUBMITTAL	DATE
DSA INITIAL SUBMITTAL	05/05/26
DSA BACKCHECK SUBMITTAL, V2	05/21/26

NO.	REVISIONS	DATE
1	ADDENDUM #1 MODEL # & WEIGHTS	08/10/26

DRAWN BY	CHECKED BY
DATE ISSUED 05/21/2026	SCALE NONE
PROJ. NO. 2501500	
SHEET NO. E0.2	



- 5 3/4" C. - #210 & 1#10 GRD TO PARKING LOT LIGHTING CONTROL
PEDESTAL. REPLACE EXISTING SPARE 30A/1P CIRCUIT BREAKER WITH
15A/1P AND CONNECT TO NEW STEP DOWN TRANSFORMER. CIRCUIT
SHALL NOT BE CONTROLLED BY LIGHTING CONTROLS AND MUST
PROVIDE ALL DAY AND NIGHT POWER.



**2455 The Alameda
Santa Clara, CA 95050
tel: 408.985.7200
fax: 408.985.7260
www.VerdeDesignInc.com**

STAMP



CONSULTANT

SHEET TITLE

ELECTRICAL PLAN

PROJECT NAME

ATHLETIC OUTDOOR
COURTS - SOCCER
SCOREBOARD PROJECT

PROJECT ADDRESS

3000 CAMPUS HILL DRIVE
LIVERMORE, CA 94551

SUBMITTAL	DATE
DSA INITIAL SUBMITTAL	05/05/20
DSA BACKCHECK SUBMITTAL, V2	05/21/20

NO.	REVISIONS	DATE
1	ADDENDUM #1 MODEL # & WEIGHTS	08/10/2018

DRAWN BY

CHECKED BY _____

DATE ISSUED _____

05/21/2026

SCALE


E
1"=20'-0"

PROJ. NO.

2501500

SHEET NO.


E1.0

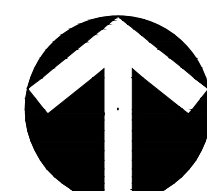

NORTH



ALL IDEAS, DESIGNS, ARRANGEMENTS, AND PLANS INDICATED OR REPRESENTED BY THIS DRAWING ARE OWNED BY AND THE PROPERTY OF VERDE DESIGN, INC. AND WERE CREATED, EVOLVED, AND DEVELOPED FOR USE ON AND IN CONNECTION WITH THE SPECIFIED PROJECT. NONE OF SUCH IDEAS, DESIGNS, ARRANGEMENTS OR PLANS SHALL BE USED, REPRODUCED, OR PUBLISHED BY ANY METHOD, IN WHOLE OR IN PART, OR DISCLOSED TO ANY PERSON, FIRM, OR CORPORATION FOR ANY PURPOSE WHATSOEVER WITHOUT WRITTEN PERMISSION OF VERDE DESIGN, INC.

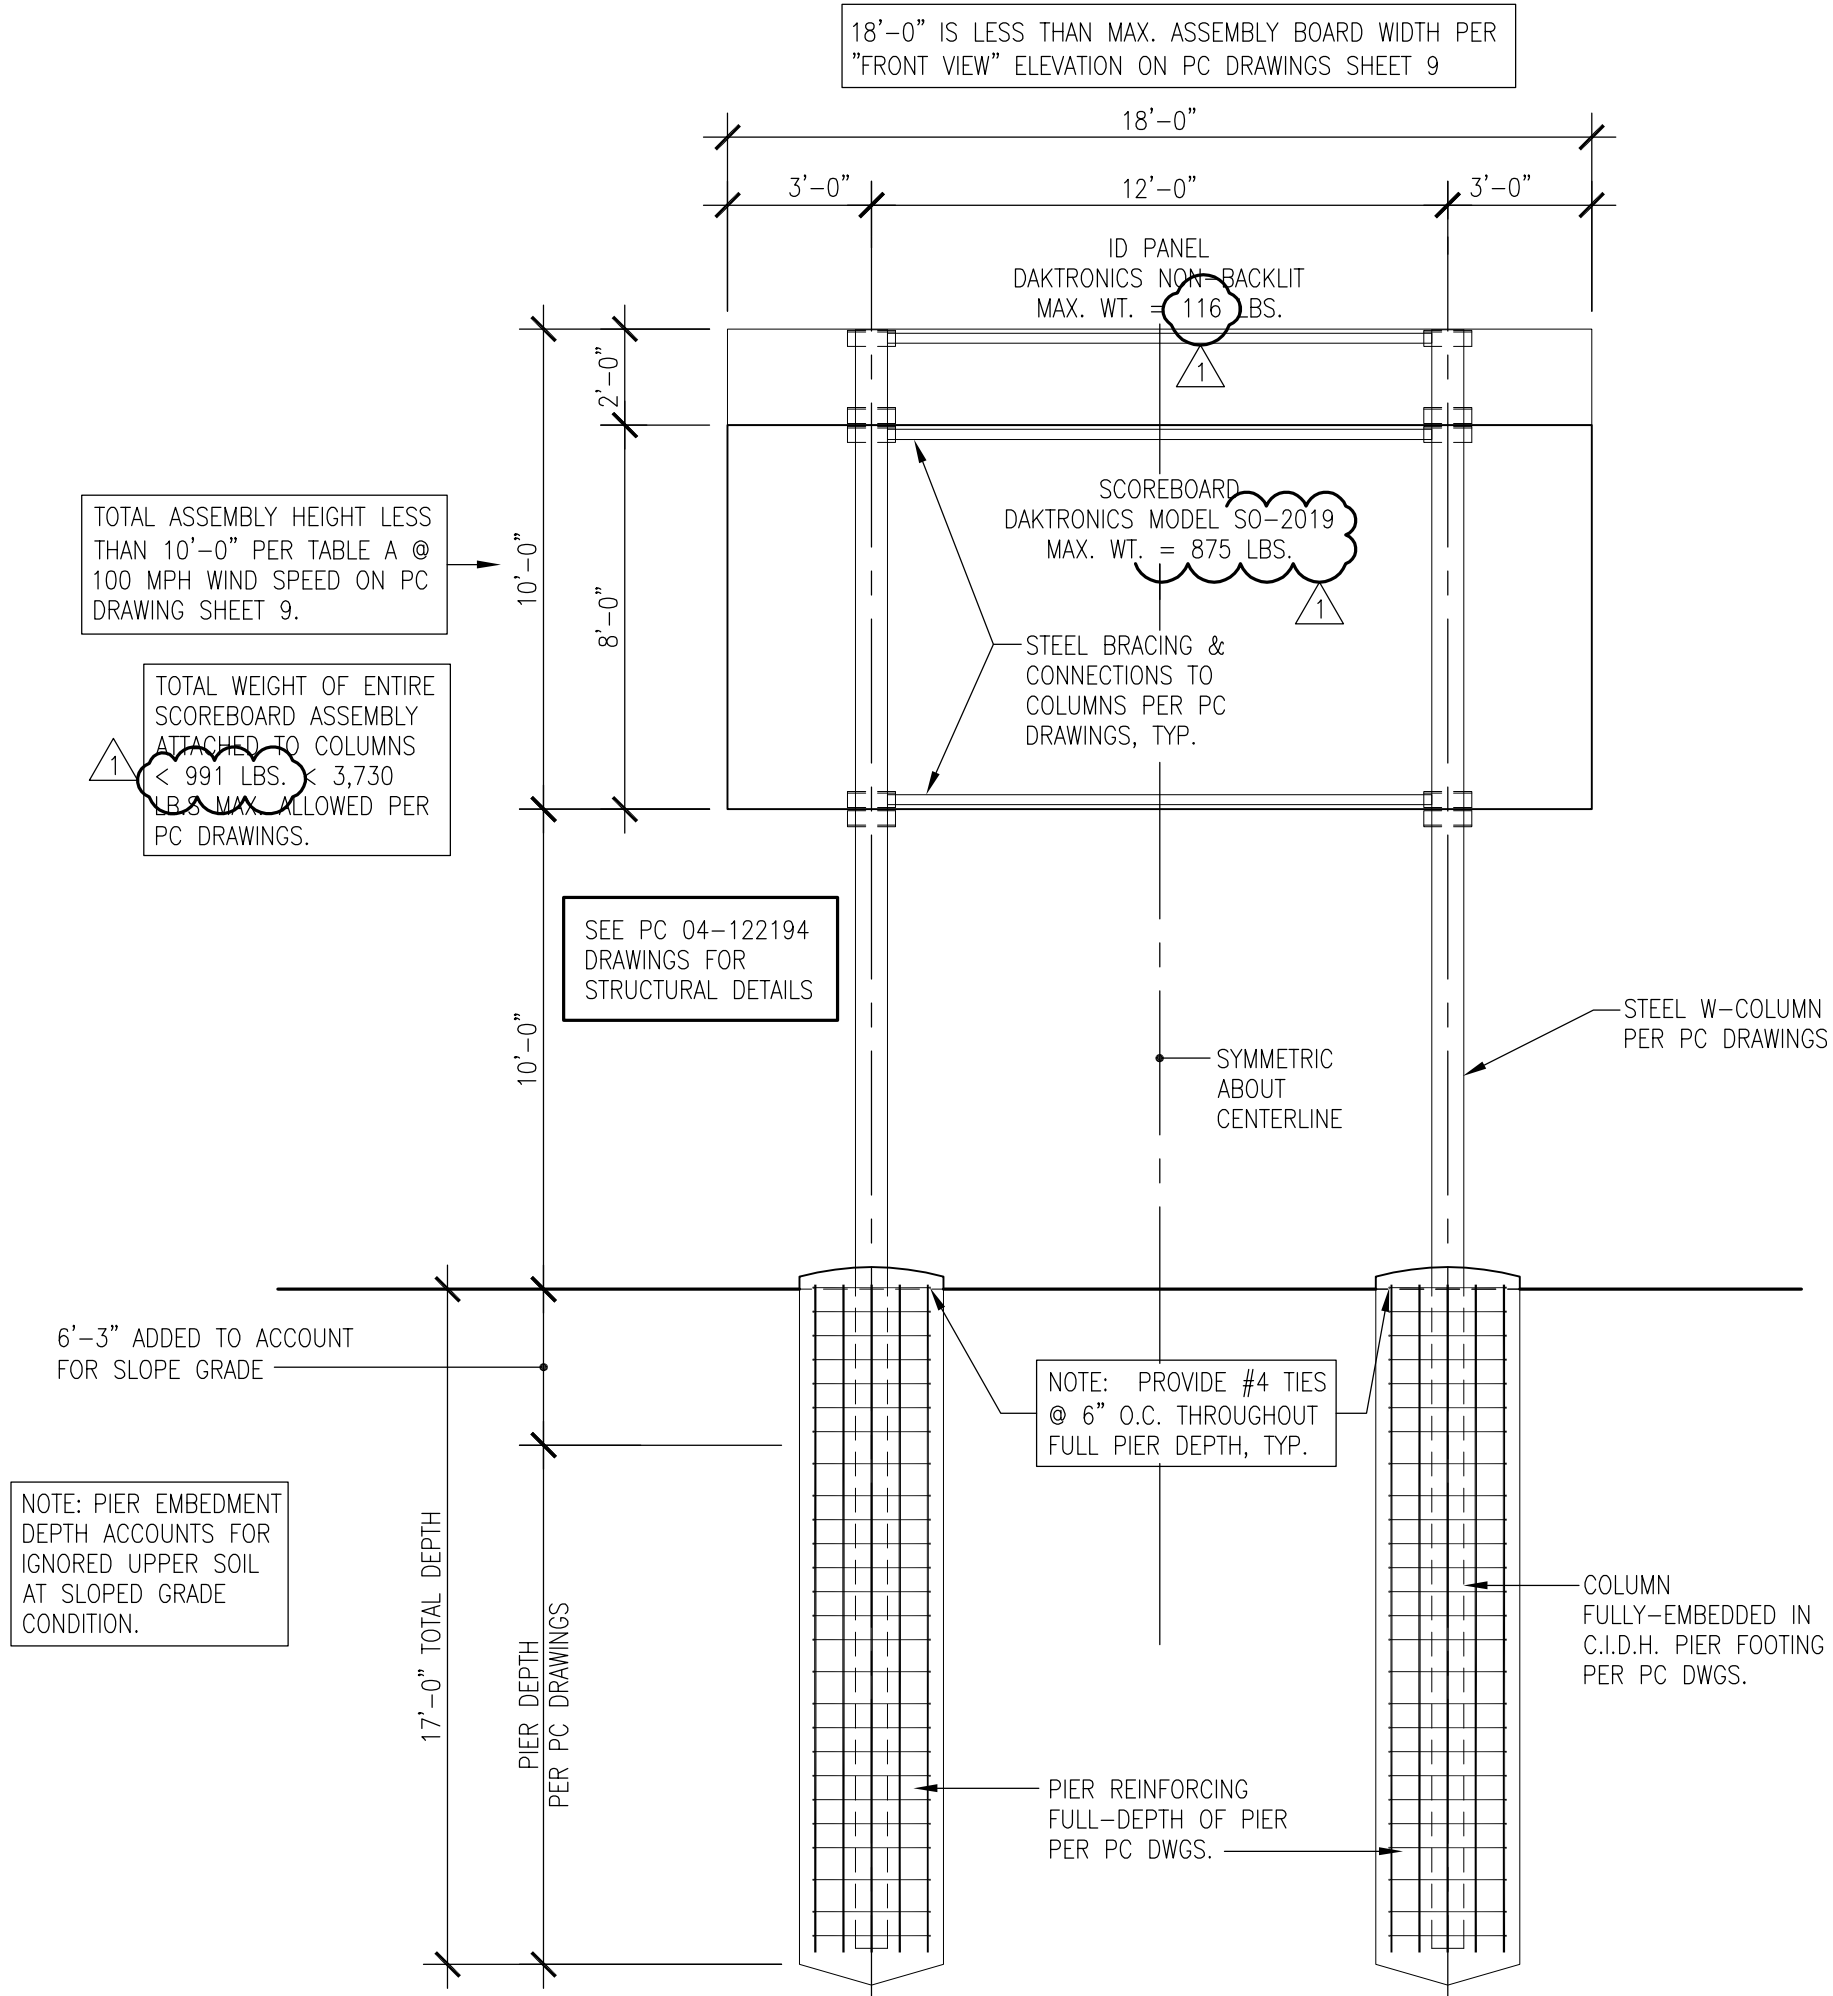

18 SOCCER SCOREBOARD SCHEMATIC FRAMING ELEVATION
DESIGN PER DAKTRONICS PC DRAWINGS

NO SCALE




VERDE DESIGN
LANDSCAPE ARCHITECTURE
CIVIL ENGINEERING
SPORT PLANNING & DESIGN

2455 The Alameda
Santa Clara, CA 95050
tel: 408.985.7200
fax: 408.985.7260
www.VerdeDesigninc.com

STAMP



CONSULTANT

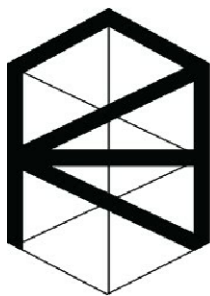

AKH

Structural Engineers, Inc

275 Tennant Avenue, Ste. 204 ph: 408.978.1970
Morgan Hill, CA 95037 AKHSE.com Job 25108

SHEET TITLE

**SCOREBOARD SCHEMATIC
ELEVATION**

PROJECT NAME

**ATHLETIC OUTDOOR
COURTS - SOCCER
SCOREBOARD PROJECT**

PROJECT ADDRESS

**3000 CAMPUS HILL DRIVE
LIVERMORE, CA 94551**

SUBMITTAL	DATE
DSA INITIAL SUBMITTAL	05/05/26
DSA BACKCHECK SUBMITTAL, V2	05/21/26

NO.	REVISIONS	DATE
1	ADDENDUM #1 MODEL # & WEIGHTS	08/10/26

DRAWN BY JJQ	CHECKED BY TDH
DATE ISSUED 08/10/2026	SCALE AS NOTED
PROJ. NO. 2501500	
SHEET NO. S1.1	